


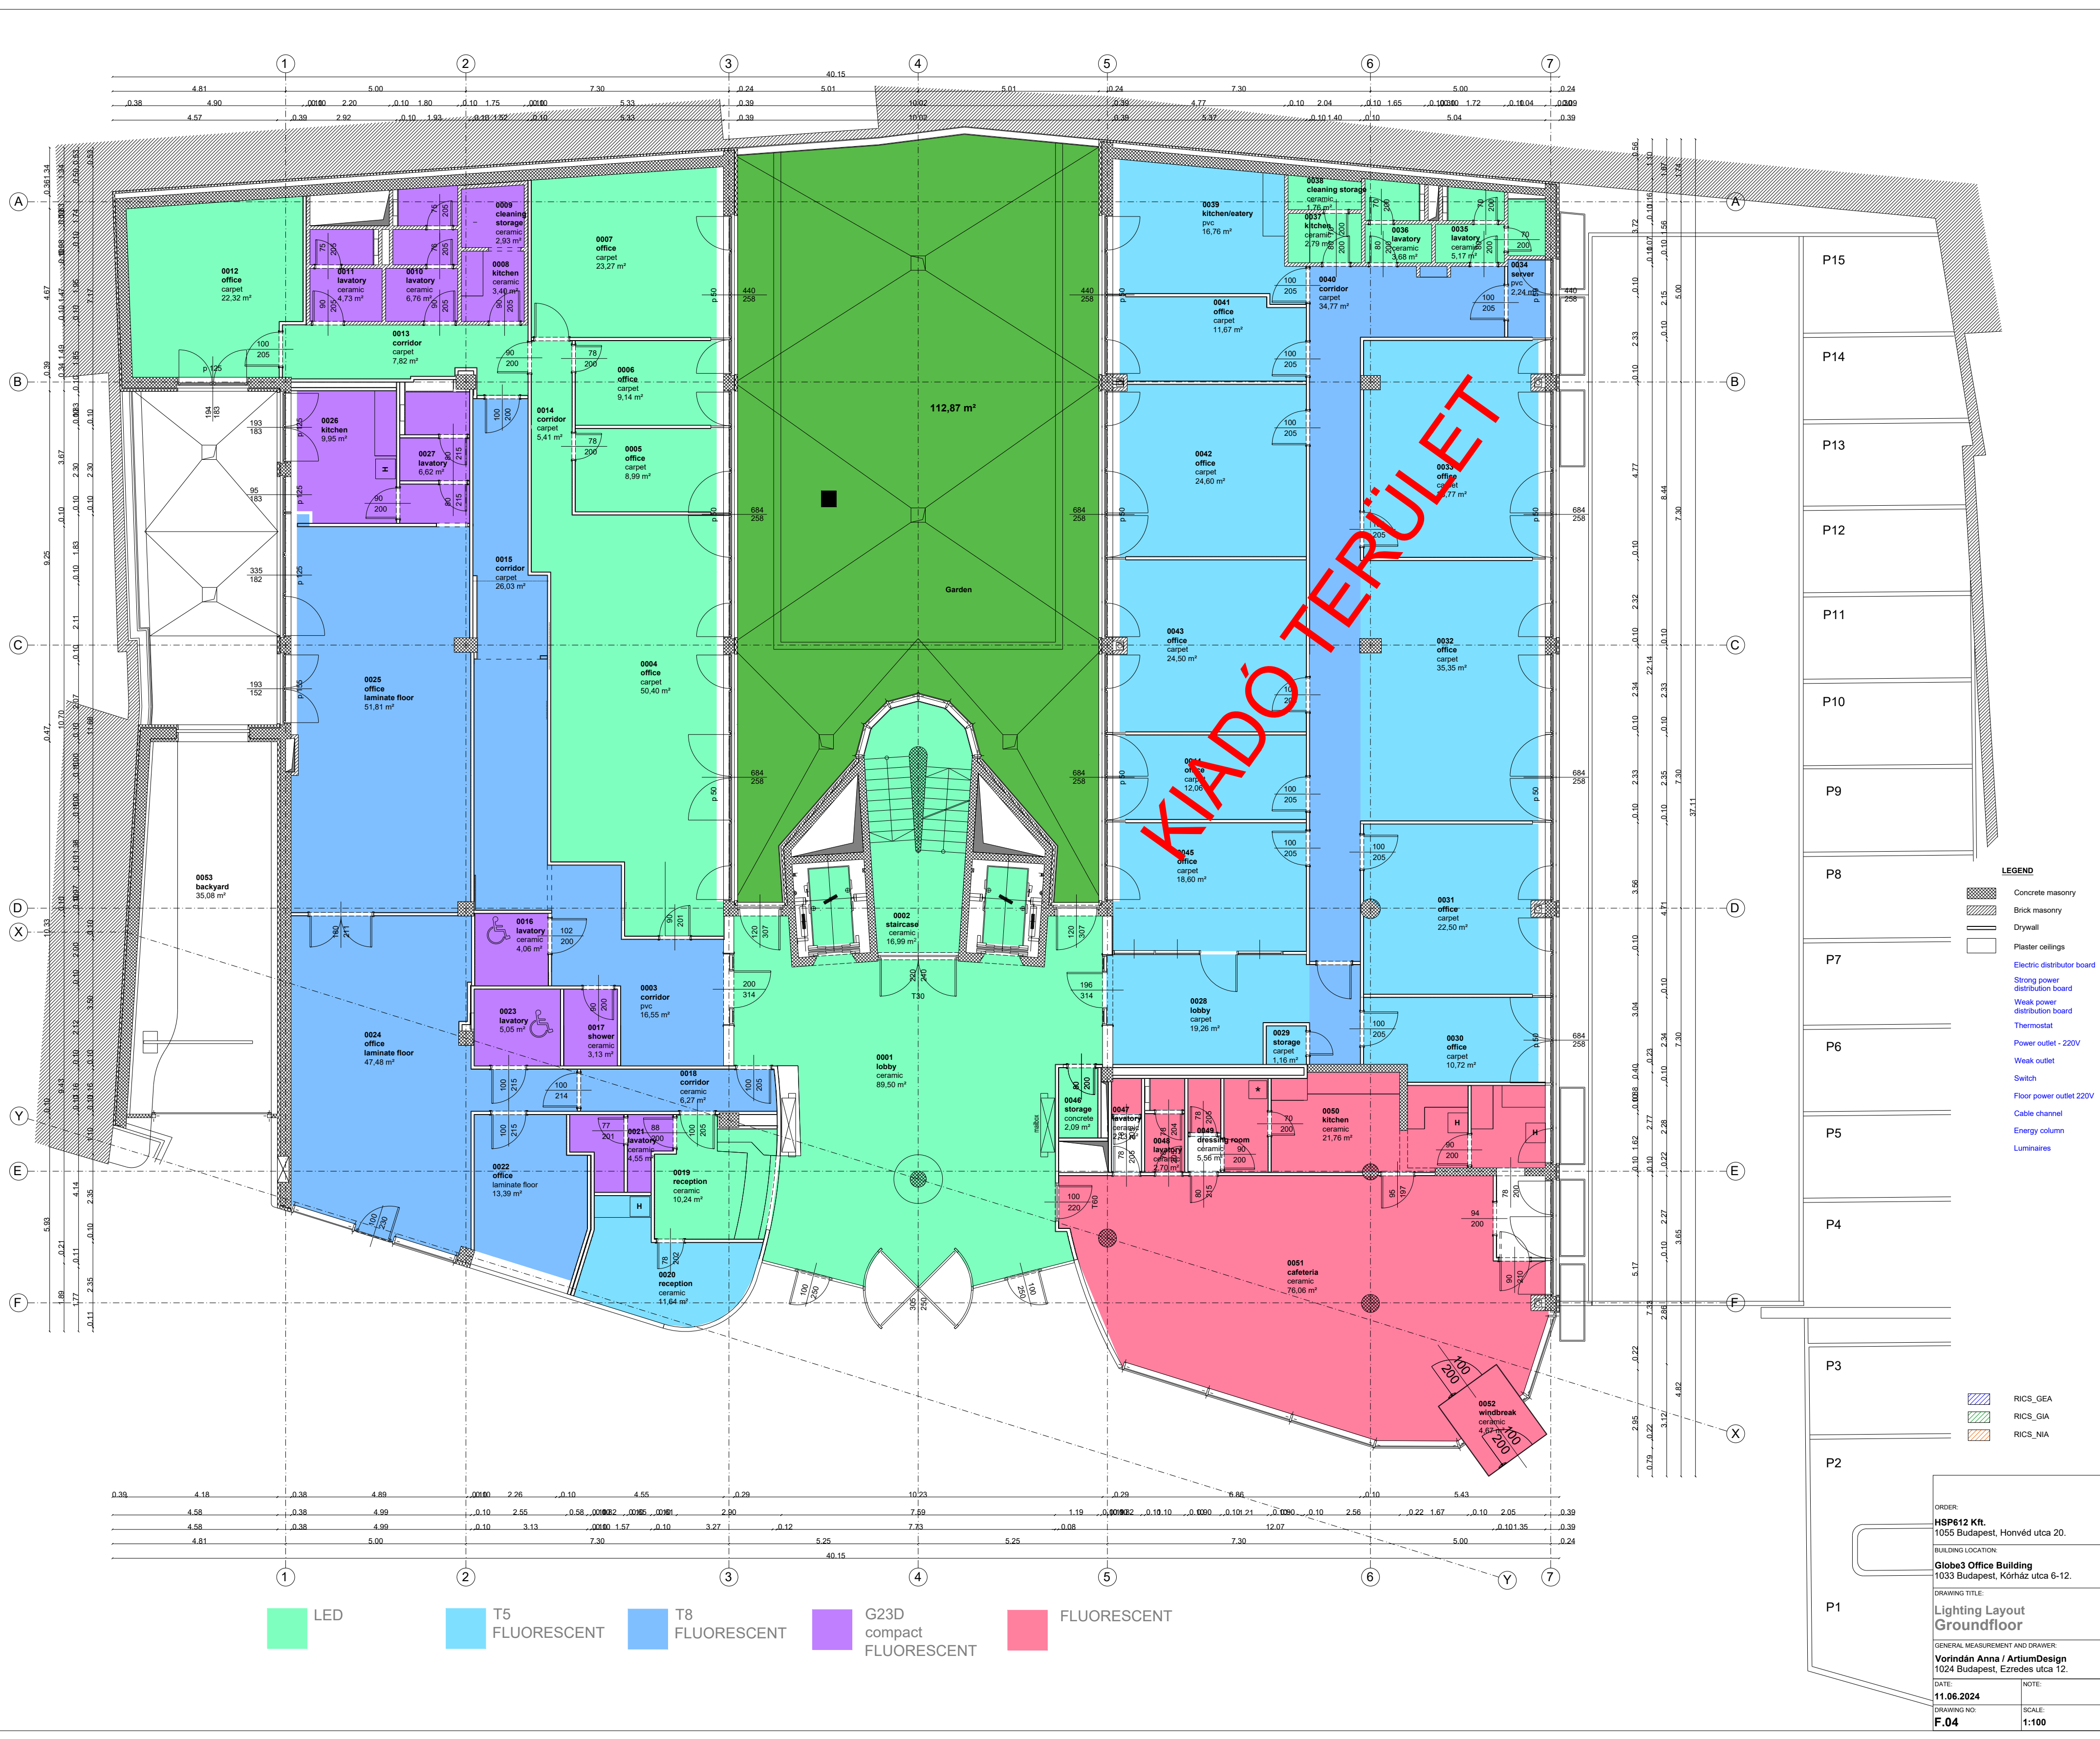

LEGEND

- Concrete masonry
- Brick masonry
- Drywall
- Plaster ceilings
- Electric distributor board
- Strong power distribution board
- Weak power distribution board
- Thermostat
- Power outlet - 220V
- Weak outlet
- Switch
- Floor power outlet 220V
- Cable channel
- Energy column
- Luminaires

- RICS_GEA
- RICS_GIA
- RICS_NIA

ORDER:
HSP612 Kft.
1055 Budapest, Honvéd utca 20.

BUILDING LOCATION:
Globe3 Office Building
1033 Budapest, Kórház utca 6-12.

DRAWING TITLE:
Lighting Layout Groundfloor

GENERAL MEASUREMENT AND DRAWER:
Vorindán Anna / ArtiumDesign
1024 Budapest, Ezredes utca 12.

DATE:
11.06.2024

DRAWING NO:
F.04

NOTE:

SCALE:
1:100